



BASE OVERLAY DRG. NO.


- PLUMBING SYMBOL SCHEDULE
- SS— BURIED SANITARY SEWER
 - SS— SANITARY SEWER
 - VENT
 - 1" PIPE SIZE
 - G— BALL VALVE
 - G— GAS PIPING
 - G— GAS VALVE
 - C.O. CLEANOUT
 - T.D. TRENCH DRAIN
 - V.T.R. VENT THRU ROOF
 - V. VENT
 - C.B. CATCH BASIN

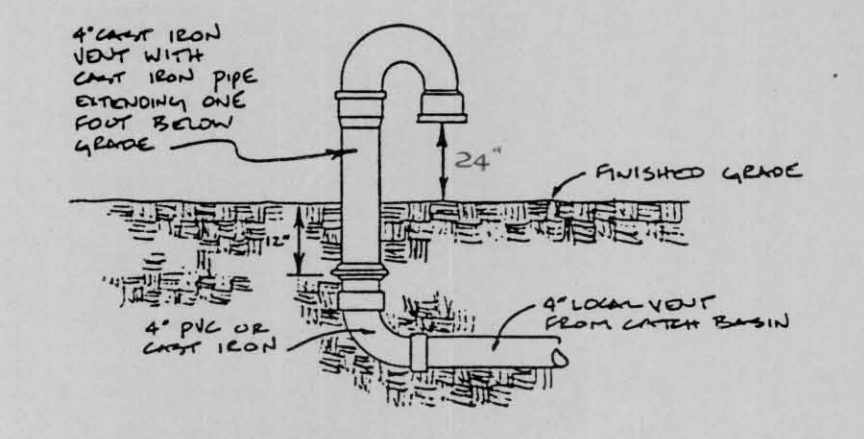


2 GOOSENECK DETAIL
NO SCALE
P-1

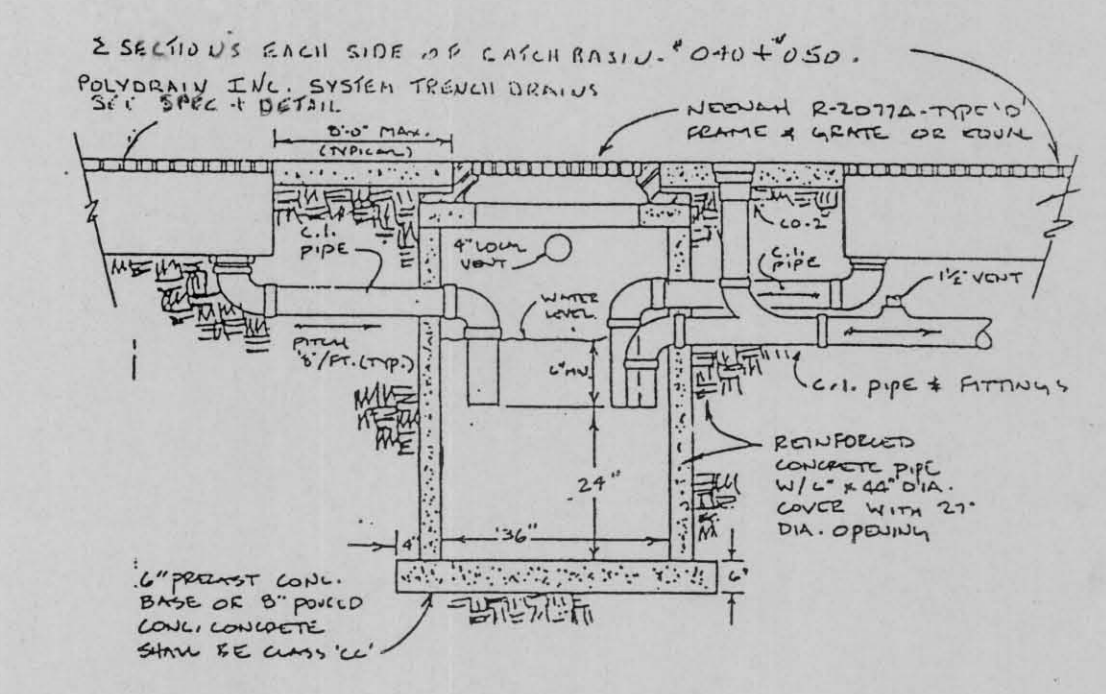

3 GARAGE CATCH BASIN DETAIL
NO SCALE
P-1

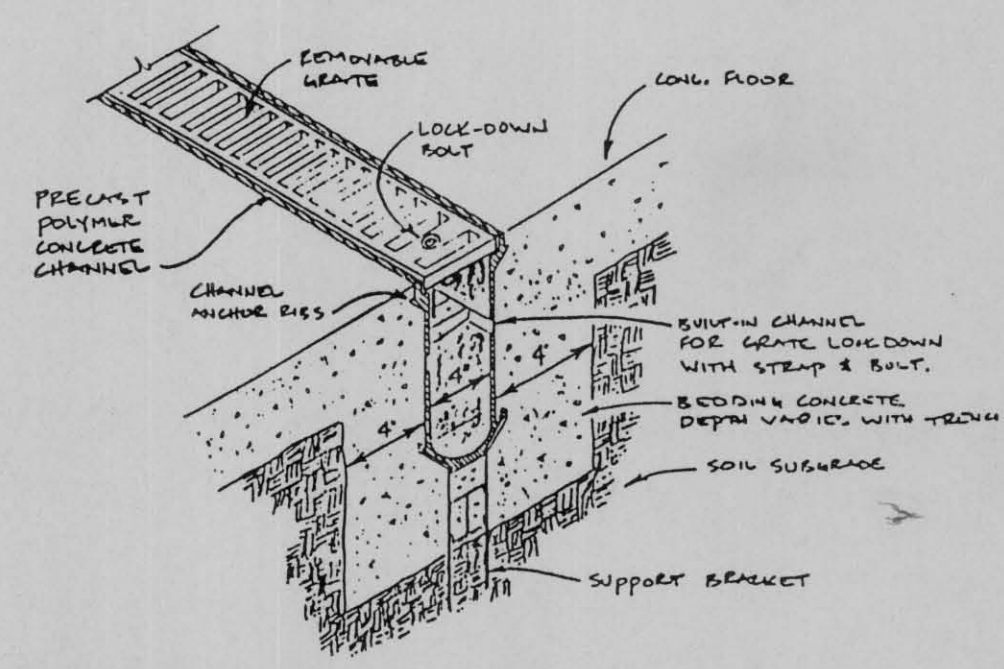

4 TRENCH DRAIN DETAIL
NO SCALE
P-1

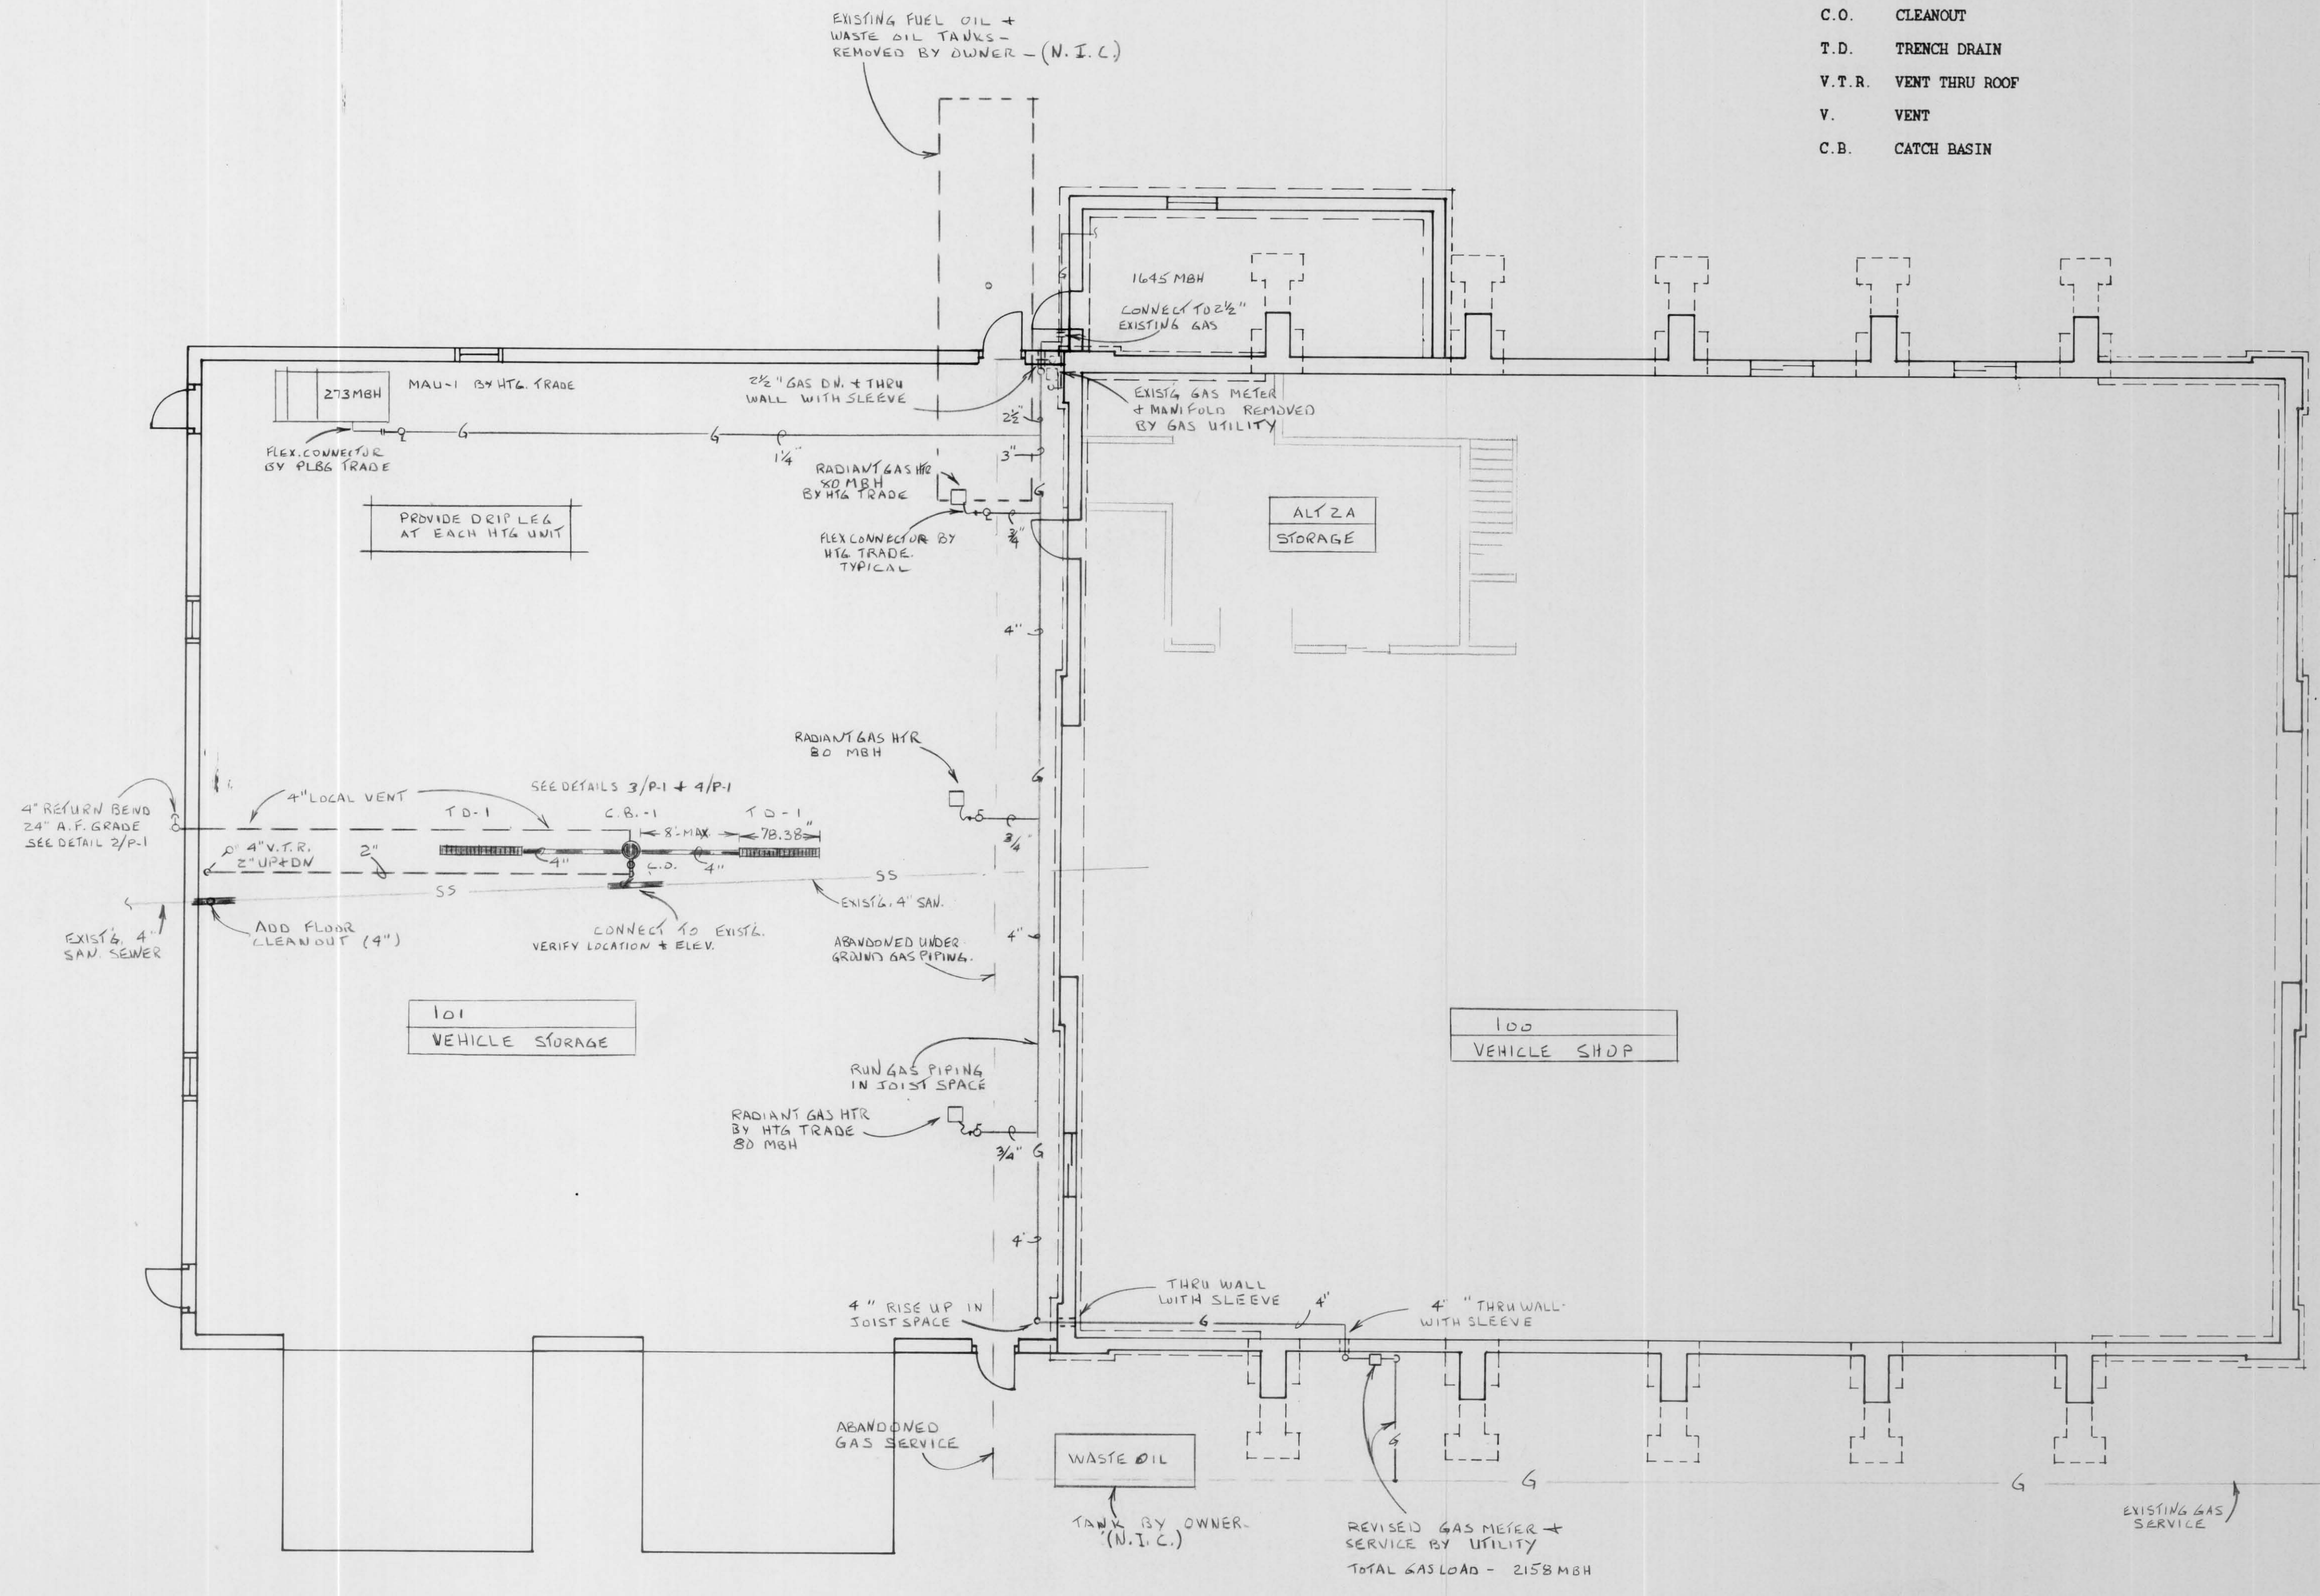

1 FLOOR PLAN
1/8" = 1'-0"
P-1



WHA
WALT HESTEKIN ASSOCIATES, LTD.
Consulting Engineers
P.O. Box 447, Eau Claire, WI 54702-0447
TELEPHONE: (715) 835-1209
WHA NO. 88104

NO.	BY	DATE	REVISIONS	ITEM	DESIGN	CHECKED



LINCOLN COUNTY
VEHICLE STORAGE ADDITION
TOMAHAWK, WISCONSIN

PLUMBING PLAN

FILE NO.
89003
DATE
AUG. 88
P1