



BASE OVERLAY DRG NO.

PLUMBING SYMBOL SCHEDULE


—SS—	BURIED SANITARY SEWER
—SS—	SANITARY SEWER
---	VENT
1"	PIPE SIZE
○	BALL VALVE
G	GAS PIPING
○	GAS VALVE
C.O.	CLEANOUT
T.D.	TRENCH DRAIN
V.T.R.	VENT THRU ROOF
V.	VENT
C.B.	CATCH BASIN

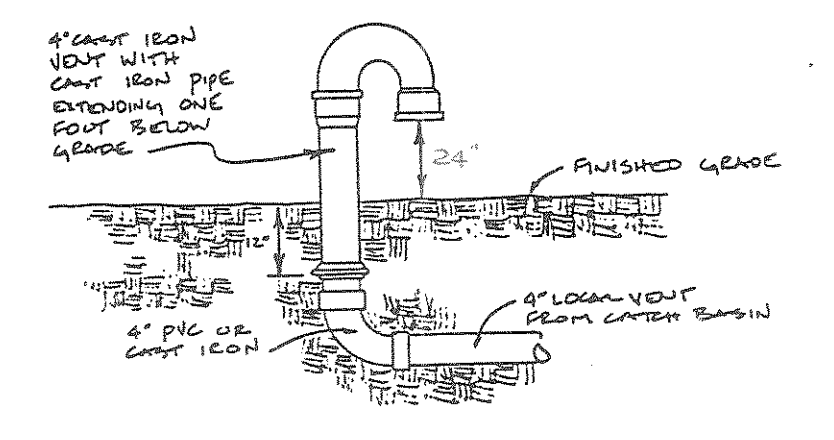


2 GOOSENECK DETAIL
P-1 NO SCALE

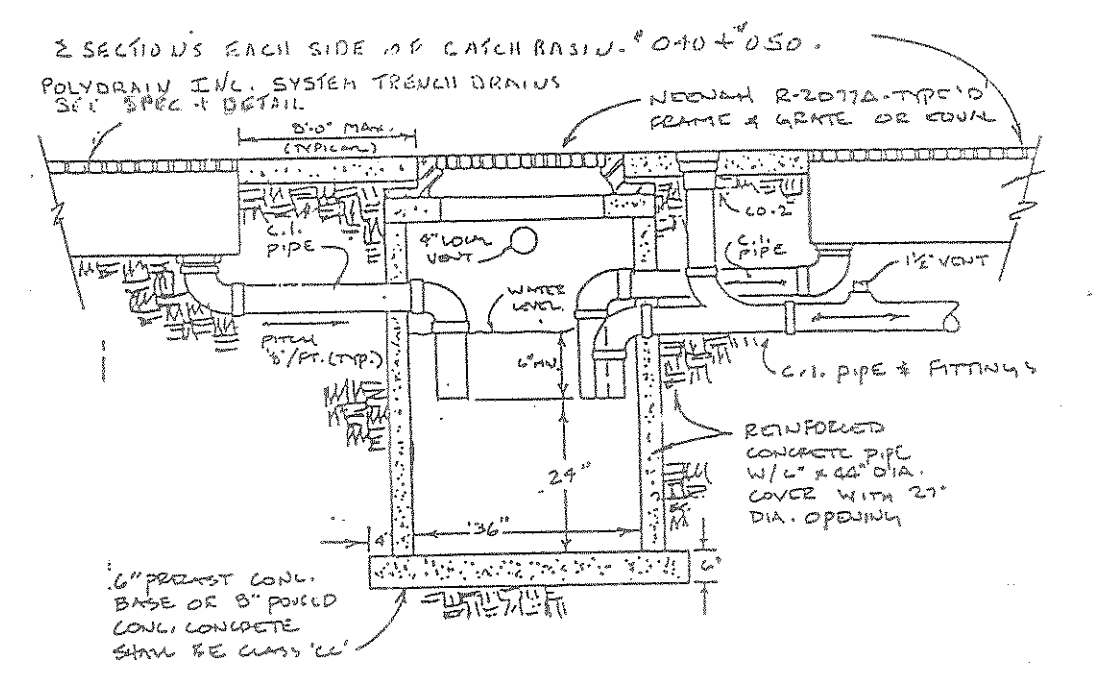


3 GARAGE CATCH BASIN DETAIL
P-1 NO SCALE

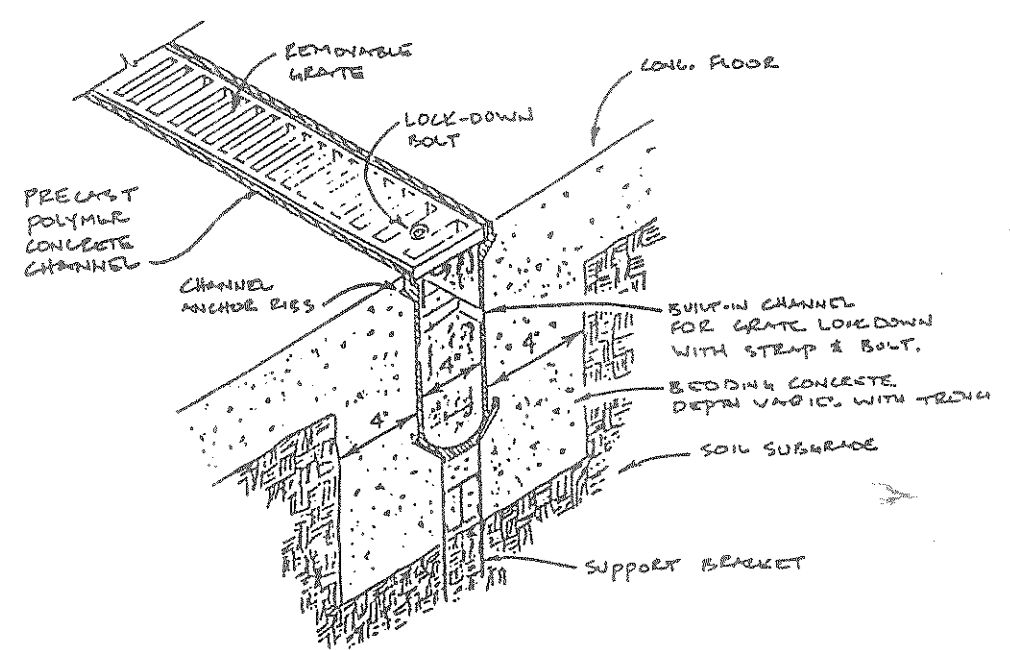


4 TRENCH DRAIN DETAIL
P-1 NO SCALE

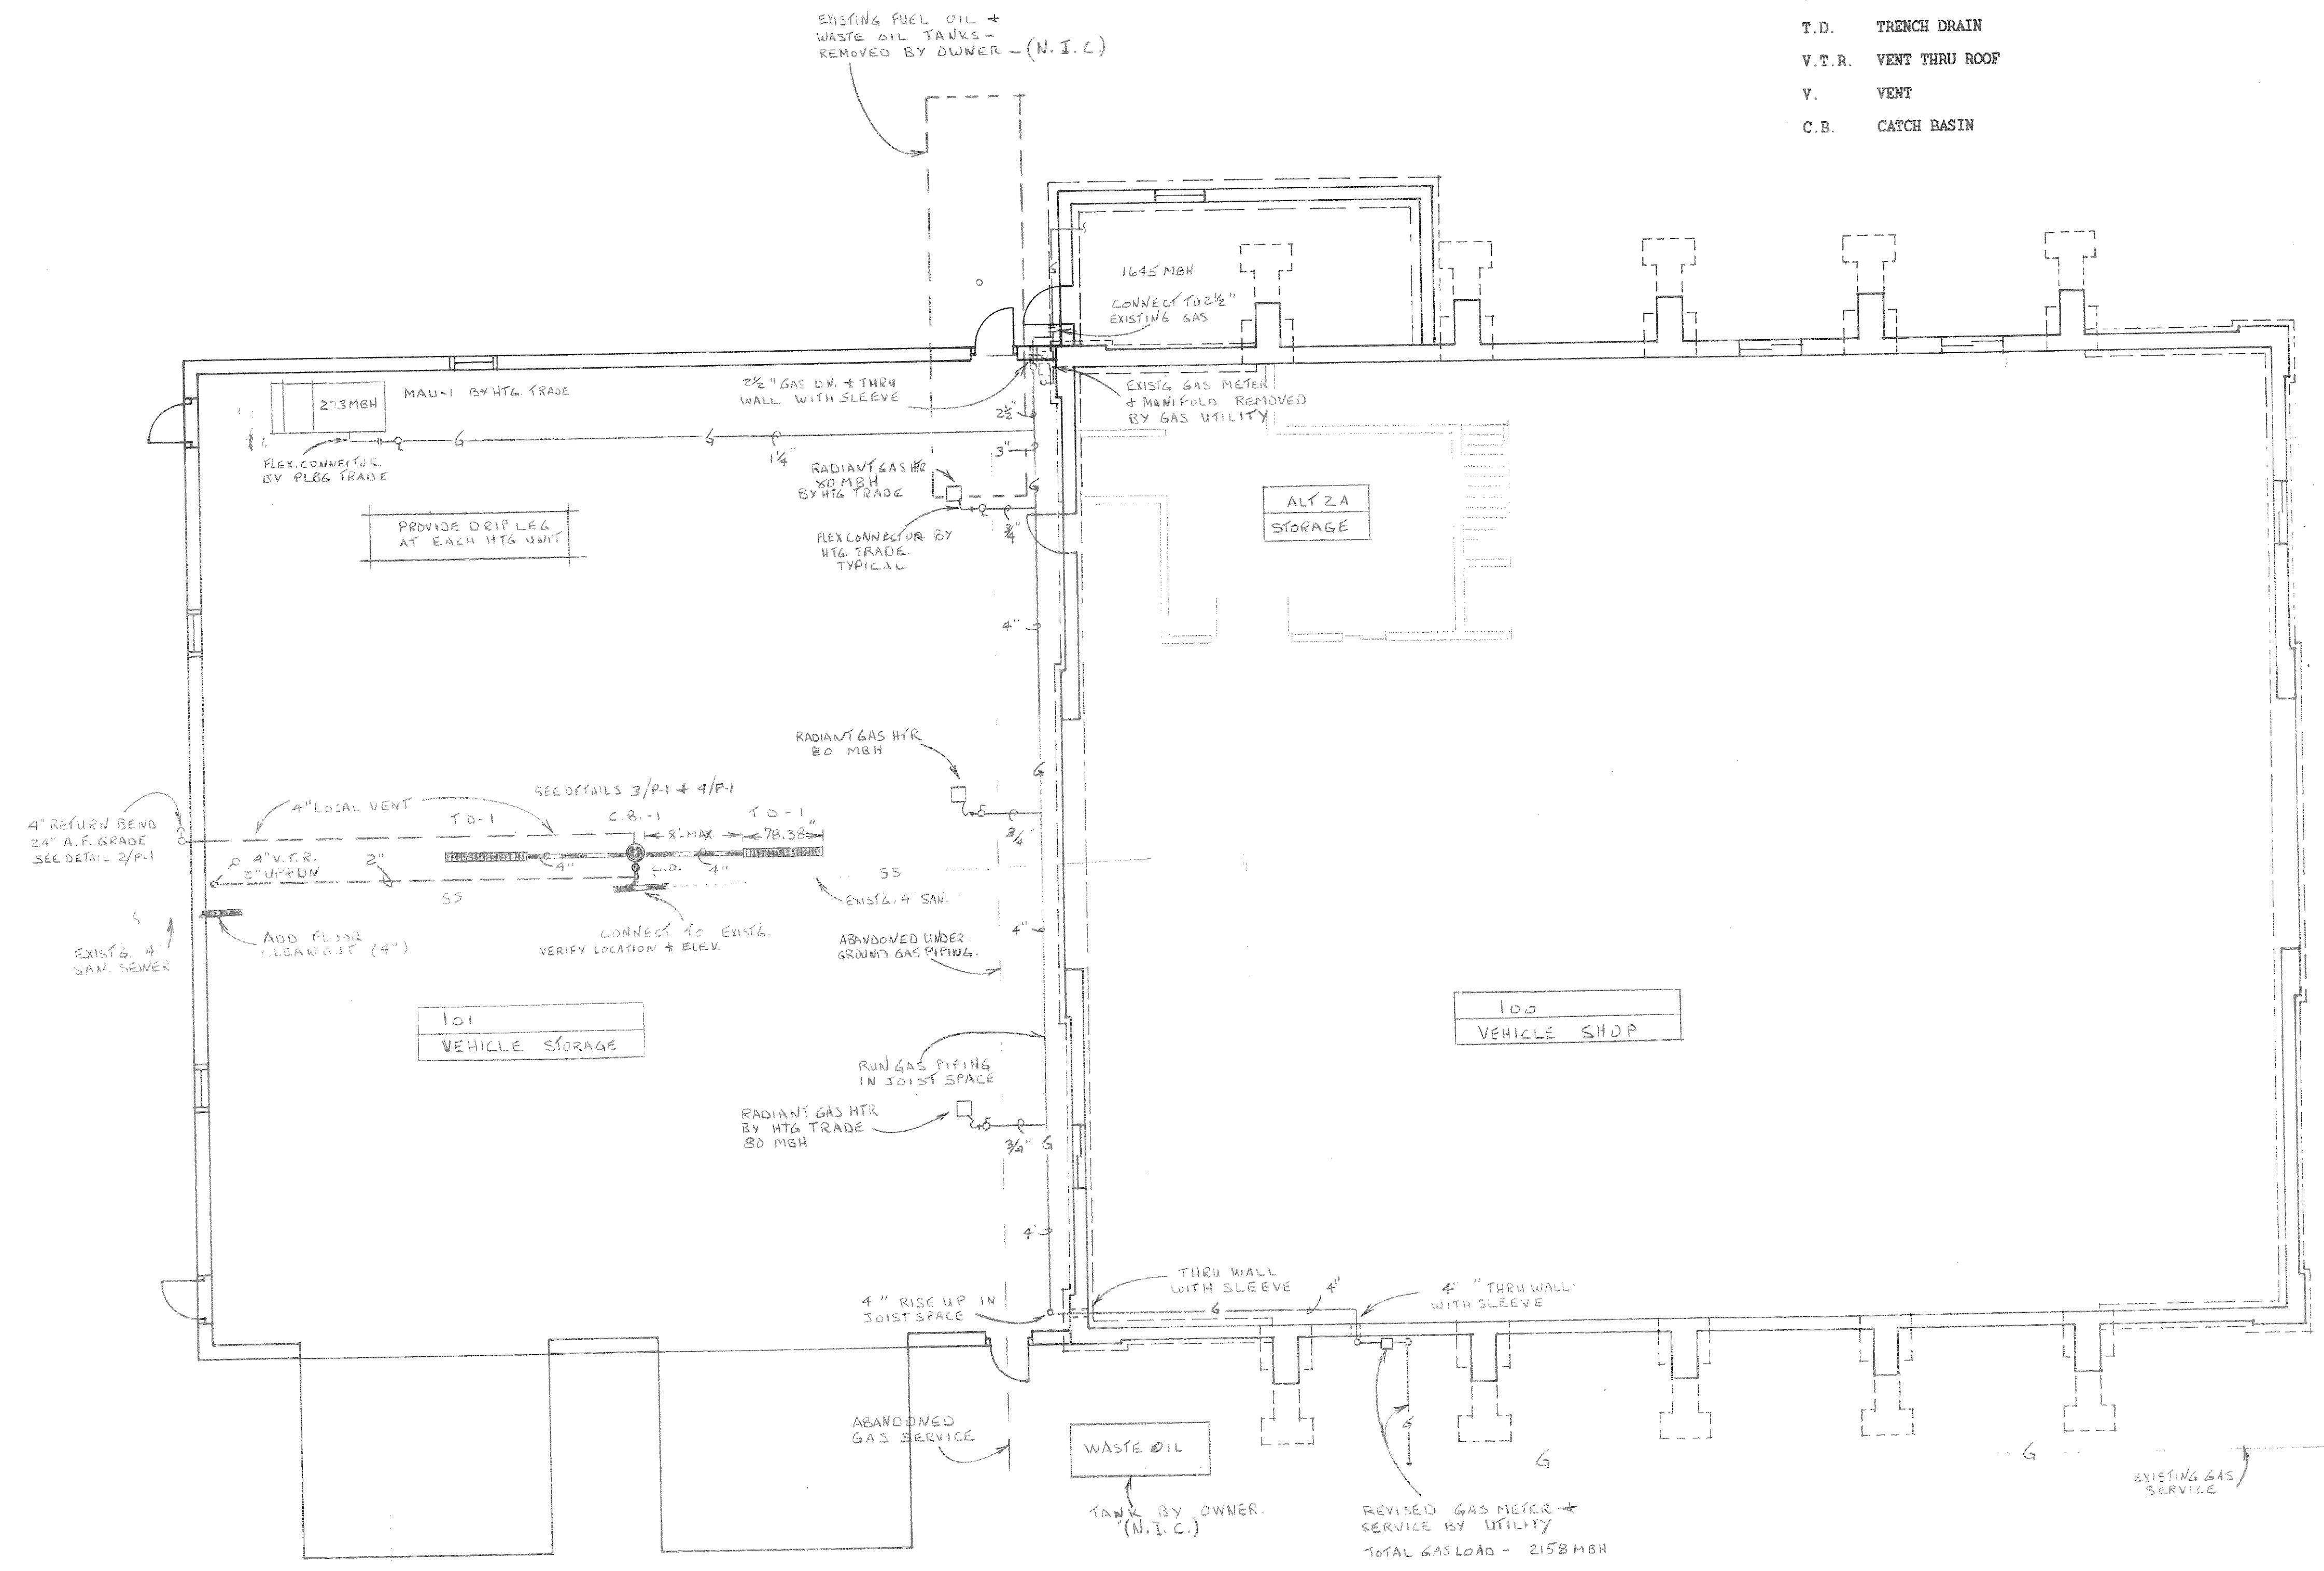

1 FLOOR PLAN
P-1 1/8" = 1'-0"

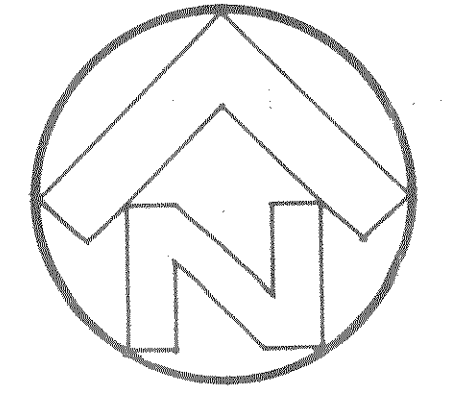

WHA
WALT HESTEKIN ASSOCIATES, LTD.
Consulting Engineers
P.O. Box 447, Eau Claire, WI 54702-0447
TELEPHONE: (715) 835-1209
WHA NO. 88104

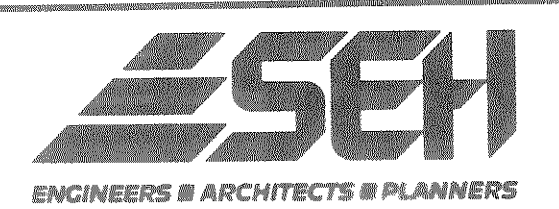

LINCOLN COUNTY
VEHICLE STORAGE ADDITION
TOMAHAWK, WISCONSIN

PLUMBING PLAN

FILE NO.
89003
DATE
AUG. 88
P1

NO.	BY	DATE	REVISIONS	ITEM	DESIGN	CHECKED